


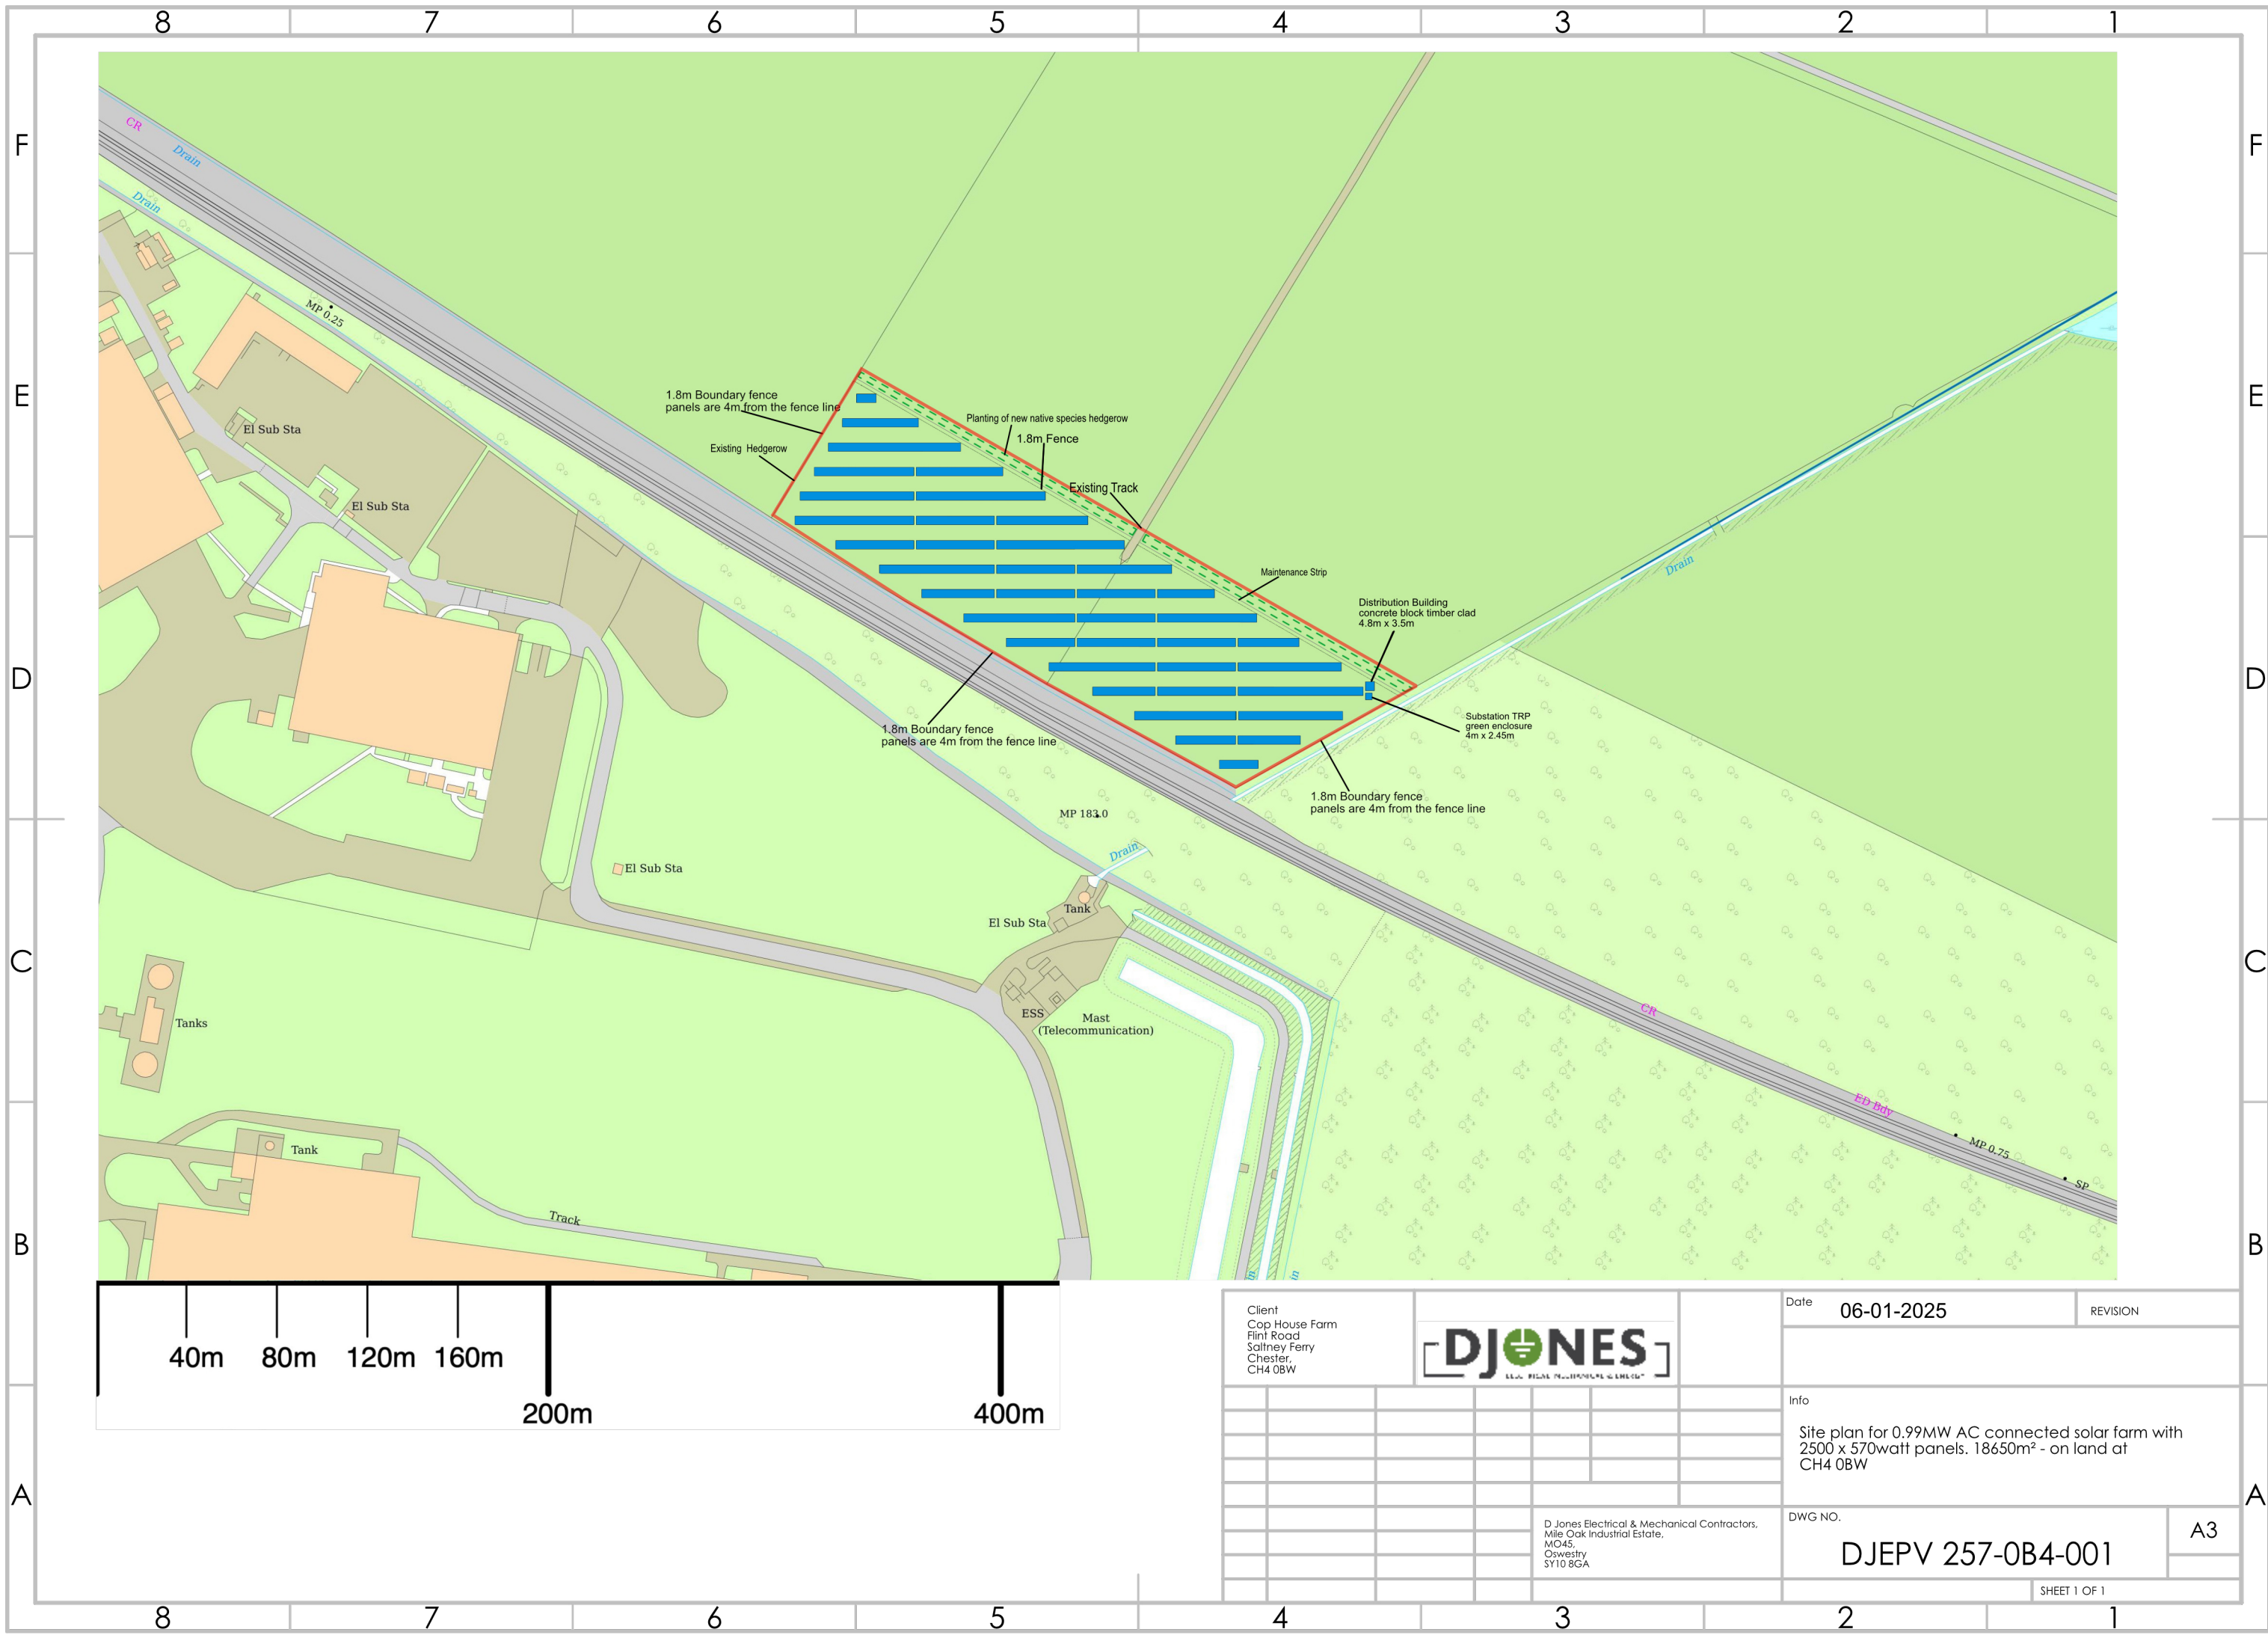

Client Cop House Farm Flint Road Saltney Ferry Chester, CH4 0BW					DJONES Electrical & Mechanical Contractors					Date 06-01-2025					REVISION									
										Info														
										Site plan for 0.99MW AC connected solar farm with 2500 x 570watt panels. 18650m ² - on land at CH4 0BW														
										DWG NO.					A3									
										D Jones Electrical & Mechanical Contractors, Mile Oak Industrial Estate, MO45, Oswestry SY10 8GA										DJEPV 257-OB4-001				
																				SHEET 1 OF 1				